


1 LIGHTING PLAN
SCALE: 1"=30'-0"

LIGHTING SCHEDULE			
SYMBOL	QTY	DESCRIPTION	MANUFACTURER
■	10	Shoebox Light	Leotek Electronics or equal
●	14	Column Light	Lumux Lighting Inc. or equal



SHOEBOX LIGHT
- SHARP CUTOFF
- DARK SKY
COMPLIANT

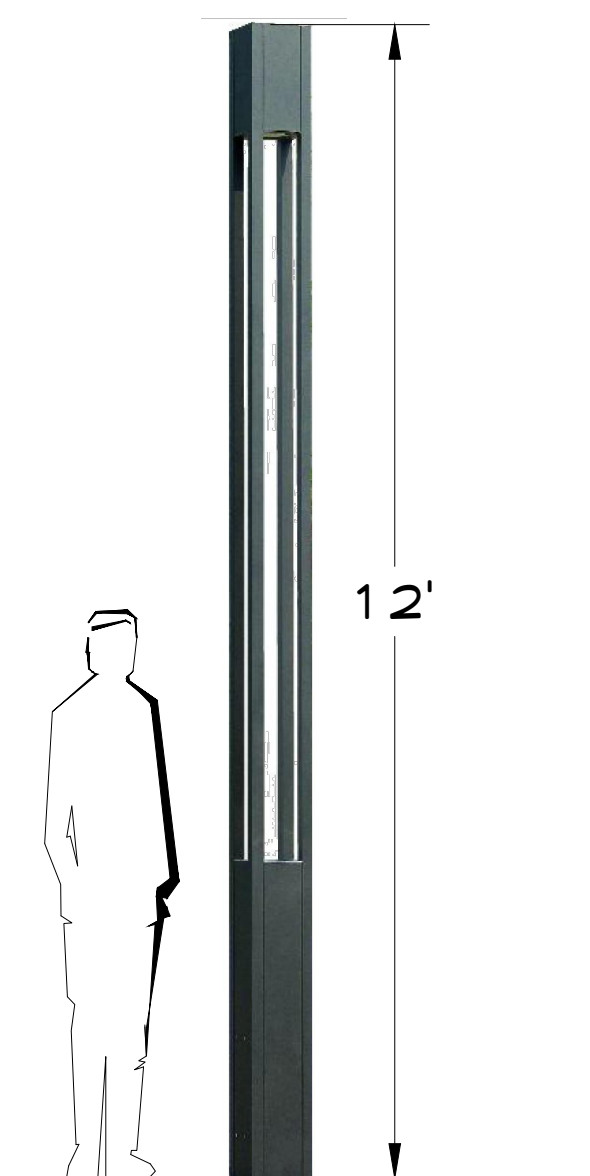

COLUMN LIGHT

2 PRECEDENT IMAGES
SCALE: N.T.S

General Notes

KEY	
○	PROPOSED DECIDUOUS TREE
○	PROPOSED FLOWERING TREE
○	PROPOSED SHRUB
○	EXISTING TREE TO REMAIN/TRANSPLANTED
■	SEED MIX 'A'
■	SEED MIX 'B'
■	SEED MIX 'C'
■	RAIN GARDEN
■	BIOFILTER
■	PERENNIAL BORDER



No.	Revision/Issue	Date

IQ
Imbiano-Quigley
Landscape Architects
31 Mamaroneck Ave
White Plains, New York 10601
admin@iqlandarch.com
(914) 232-0200

Project Name
Uno at I-Park Norwalk
761 Main Avenue
Norwalk, Wilton CT

Drawing Title
Schematic Lighting Plan

Scale As Noted	Sheet No. L-4
Date February 11, 2021	
Drawn By VA	Checked By JAI